


33KV,A2XFY HT CABLE
3CX300 SQ.MM, XLPE AL.AR.

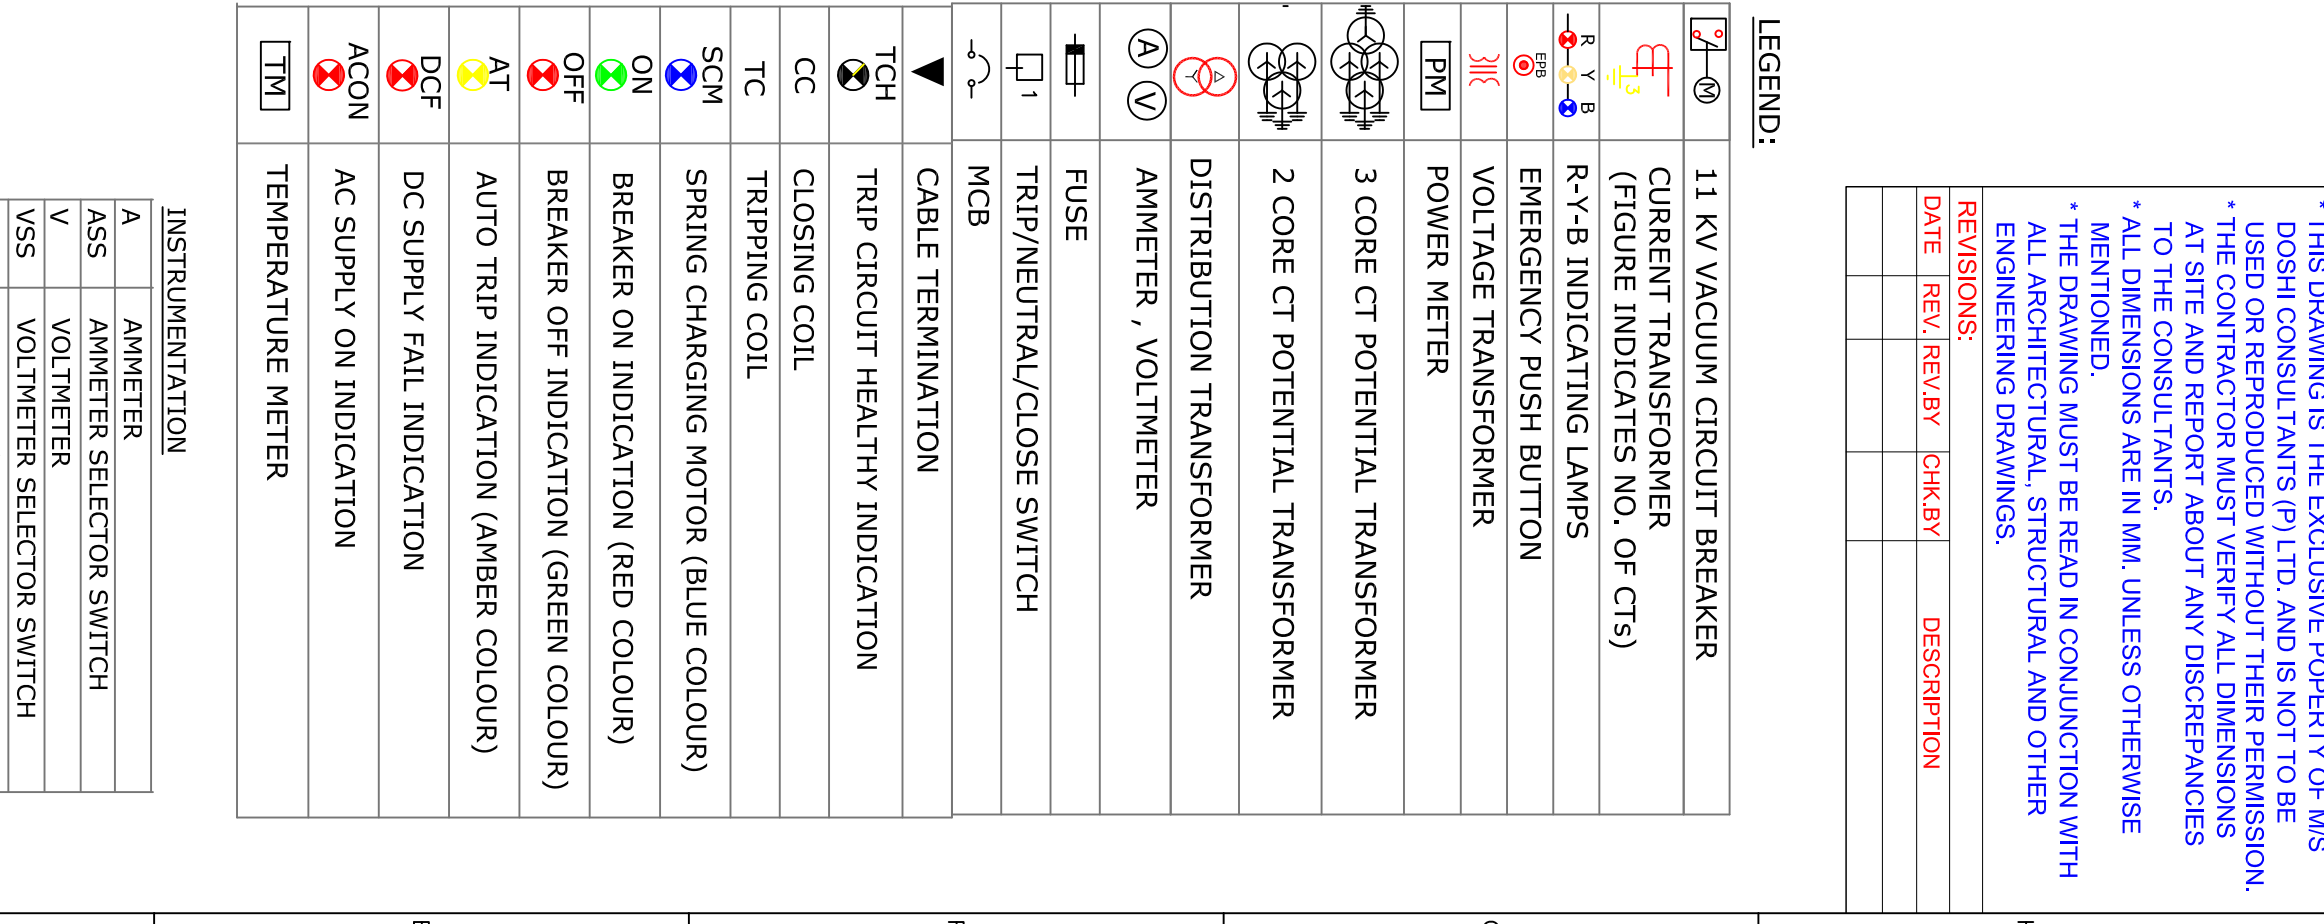

	11 KV VACUUM CIRCUIT BREAKER
	CURRENT TRANSFORMER (CURRENT INDICATES NO. OF CT'S)
	R-Y-B INDICATING LAMPS
	EMERGENCY PUSH BUTTON
	VOLTAGE TRANSFORMER
	POWER METER
	3 CORE CT POTENTIAL TRANSFORMER
	2 CORE CT POTENTIAL TRANSFORMER
	DISTRIBUTION TRANSFORMER
	AMMETER , VOLTMETER
	FUSE
	TRIP/NEUTRAL/CLOSE SWITCH
	CABLE TERMINATION
	TRIP CIRCUIT HEALTHY INDICATION
	CLOSING COIL
	TRIPPING COIL
	SPRING CHARGING MOTOR (BLUE COLOUR)
	BREAKER ON INDICATION (RED COLOUR)
	BREAKER OFF INDICATION (GREEN COLOUR)
	AUTO TRIP INDICATION (AMBER COLOUR)
	DC SUPPLY FAIL INDICATION
	AC SUPPLY ON INDICATION
	TEMPERATURE METER

DATE	REV.	MAIL NOS	CLIENT ISSUED TO	FOR STUDY DESCRIPTION
21.08.23	R0	MAIL	CLIENT	FOR STUDY

RELEASE FOR :-				TENDER DRAWING	
TITLE :-		SINGLE LINE DIAGRAM 3KV/HT VCB PANEL			
DESIGN	KRT/	19.07.23	PROJECT NO. - 626	SCALE - NTS	
DRAWN	KRT	19.07.23	DRAWING NO.		Rev
CHECKED	SHD	24.07.23			
APPROVED	SHD	24.07.23			
			626/KAP/LHT-S/DEL-601		R-00
					1,2