
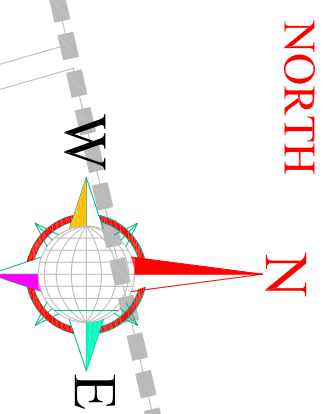


TENDER DRAWING

ANEXTURE- II A

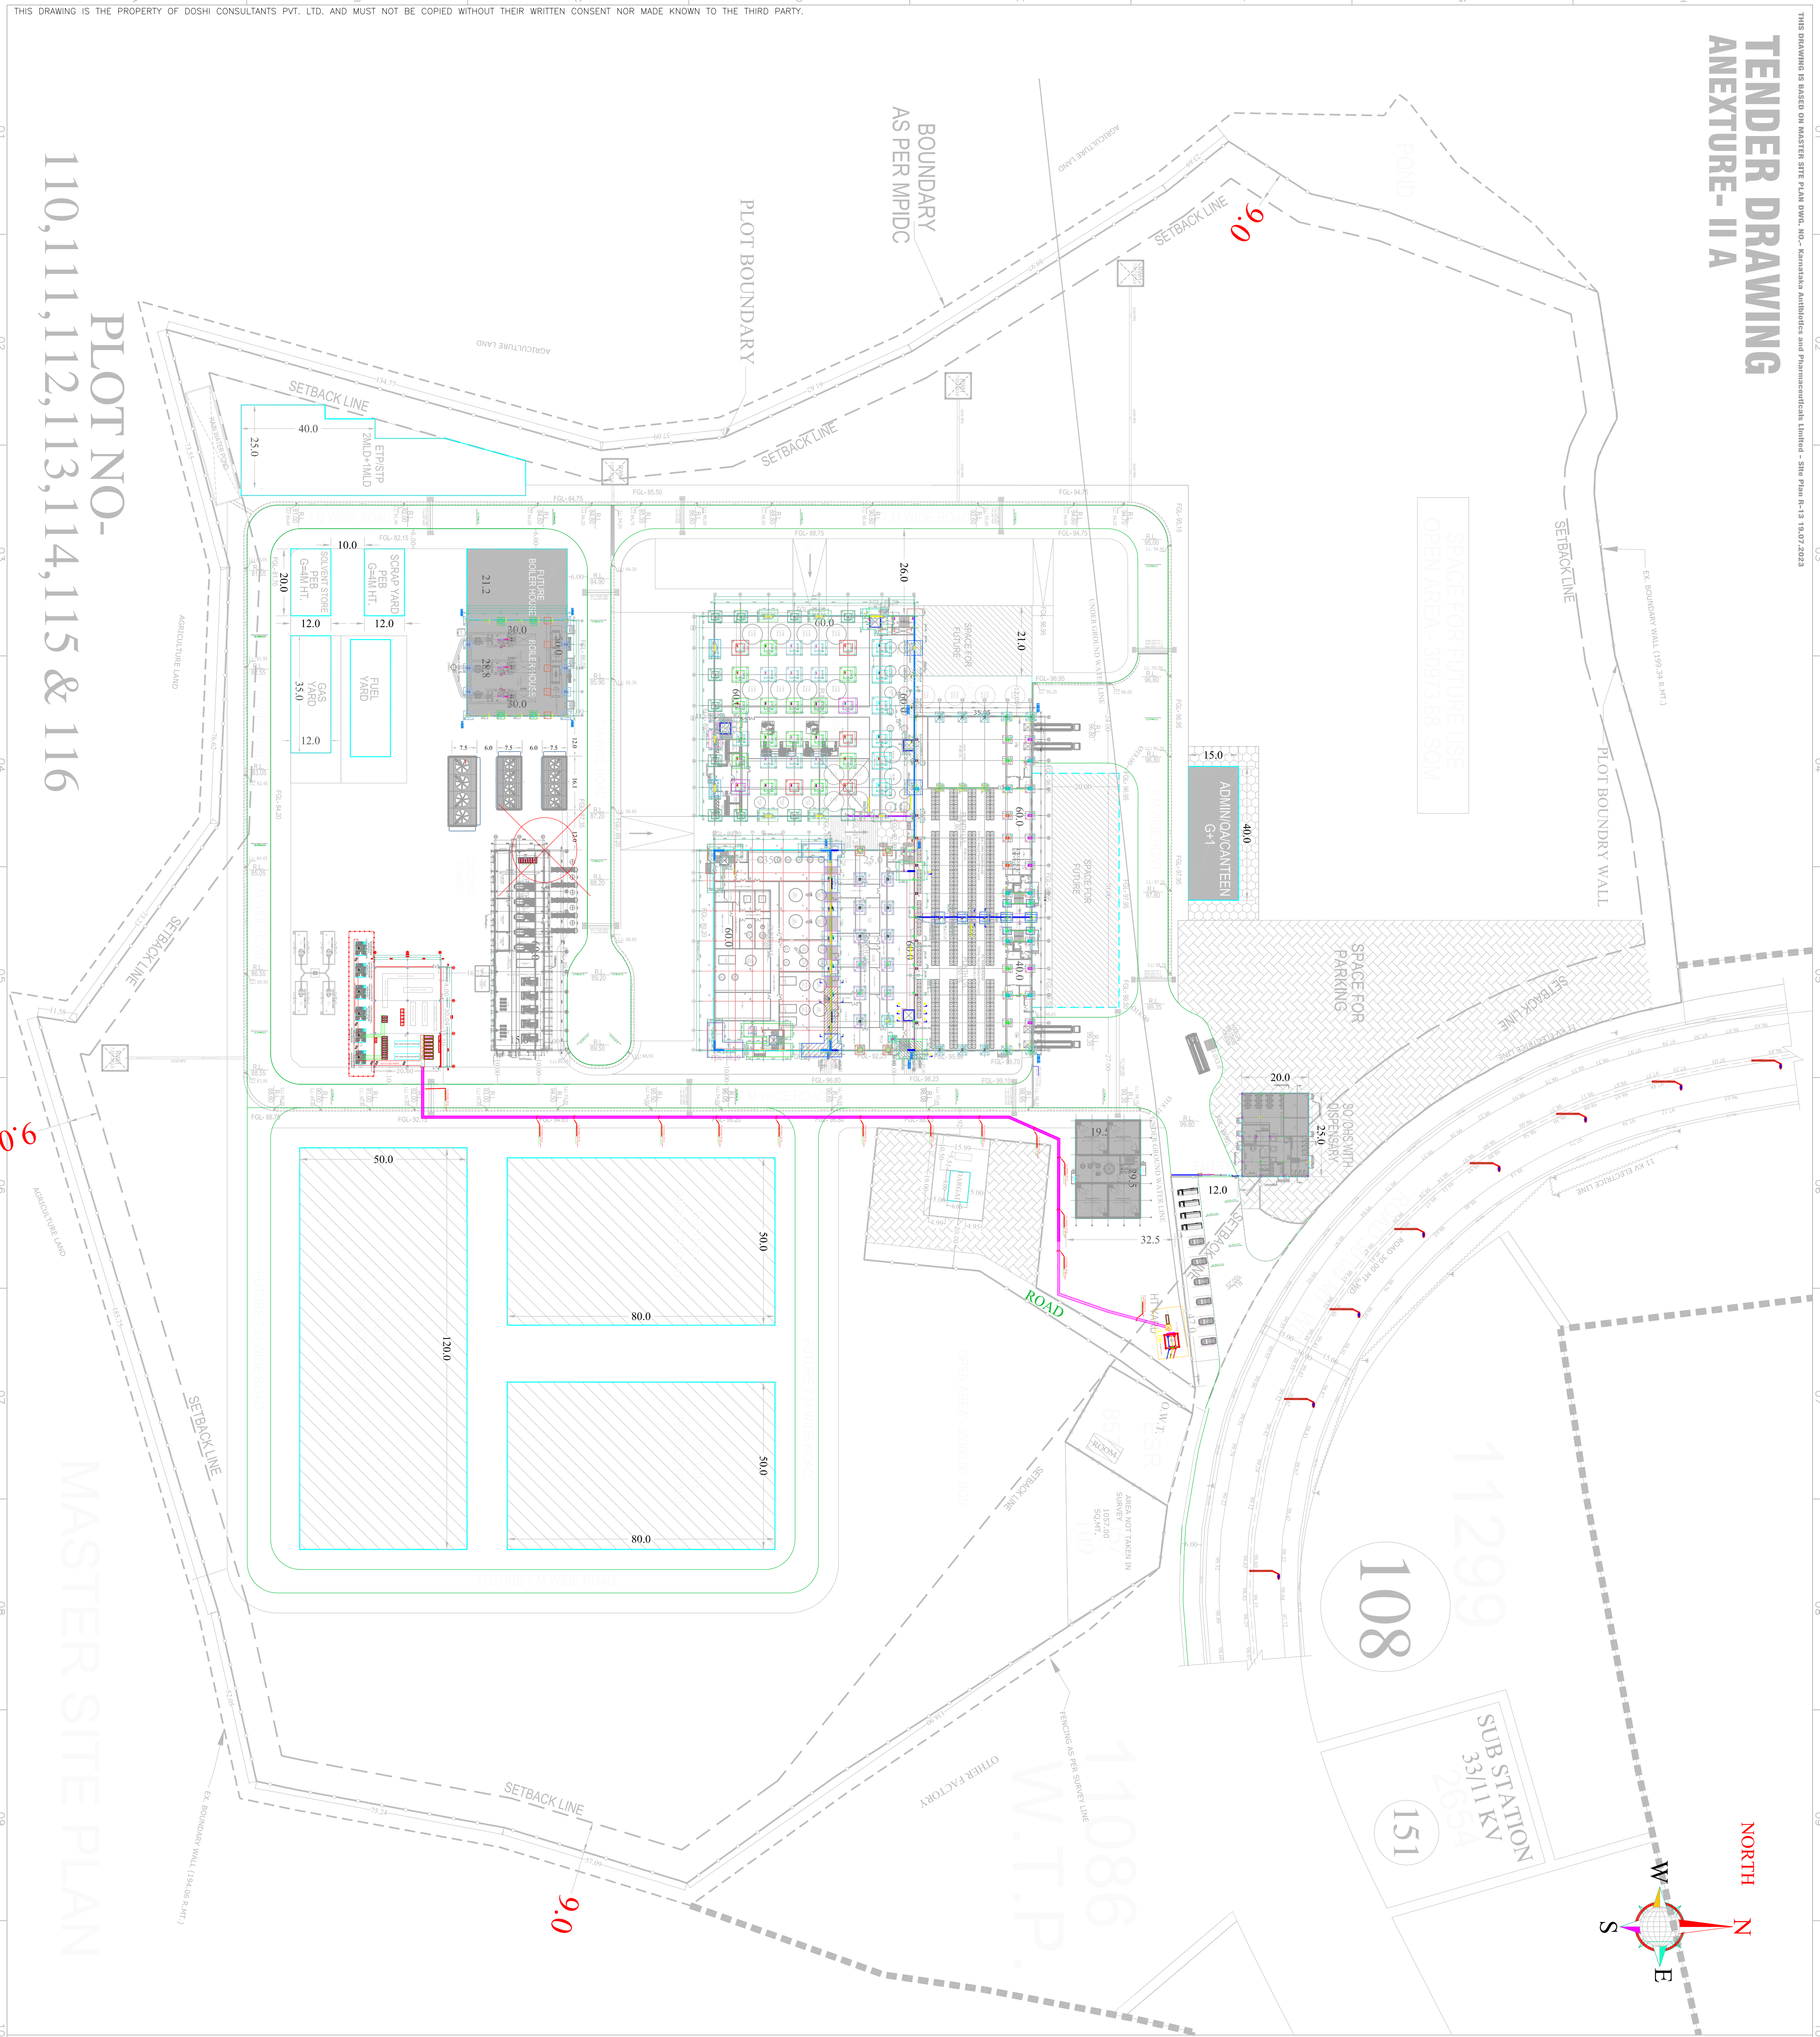


* THIS DRAWING IS THE EXCLUSIVE PROPERTY OF M/S DOSHI CONSULTANTS (P) LTD. AND IS NOT TO BE USED OR REPRODUCED WITHOUT THEIR PERMISSION.

* THE CONTRACTOR MUST VERIFY ALL DIMENSIONS AT SITE AND REPORT ABOUT ANY DISCREPANCIES TO THE CONSULTANTS.

* ALL DIMENSIONS ARE IN MM. UNLESS OTHERWISE MENTIONED.

REVISIONS:

DATE	REV.	REV. BY	CHK. BY	DESCRIPTION

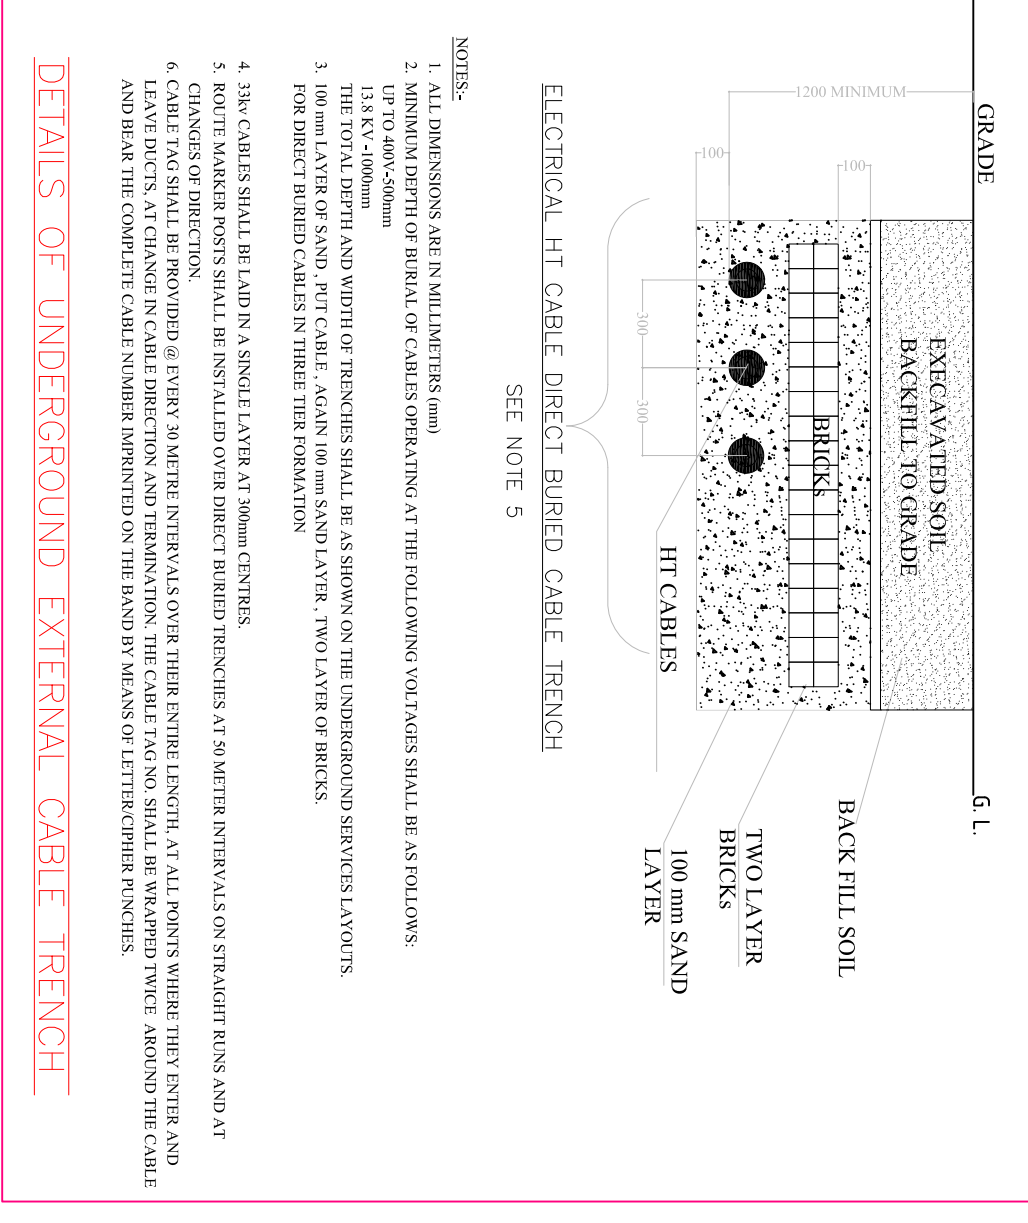

26.08.23	R0	MAIL	CLIENT	TENDERING/ APPROVAL
DATE	REV.	NOS	ISSUED TO	DESCRIPTION

CLIENT:-

KARNATAKA ANTIBIOTICS AND PHARMACEUTICALS LTD.

PROJECT LOCATION:-

VIKRAM UDYOGPURI , UJJAIN , MP

PROJECT CONSULTANT:-

Doshi Consultants (P) Ltd.
401-CITY CENTER, 370 M.G. ROAD, INDOR-1 (M.P.) INDIA.
PHONE:- +91-731-2341457, +91-731-4011555
E-Mail: proj.ctcs@doshicons.com

DRAWING TITLE:

MASTER SITE PLAN
HT YARD WITH CABLE ROUTING LAYOUT

RELEASED FOR:-

TENDER & APPROVAL

DESIGNED BY:	KRT1	22.07.2023
DRAWN BY:	KRT1	22.07.2023
CHECKED BY:	SK. DOSHI	24.07.2023
APPROVED BY:	BK. DOSHI	24.07.2023
SCALE:	N.T.S	
DRAWING No.	626-KAPL-SP-EL-HT-600	VER. No.
		REV. No. 00