



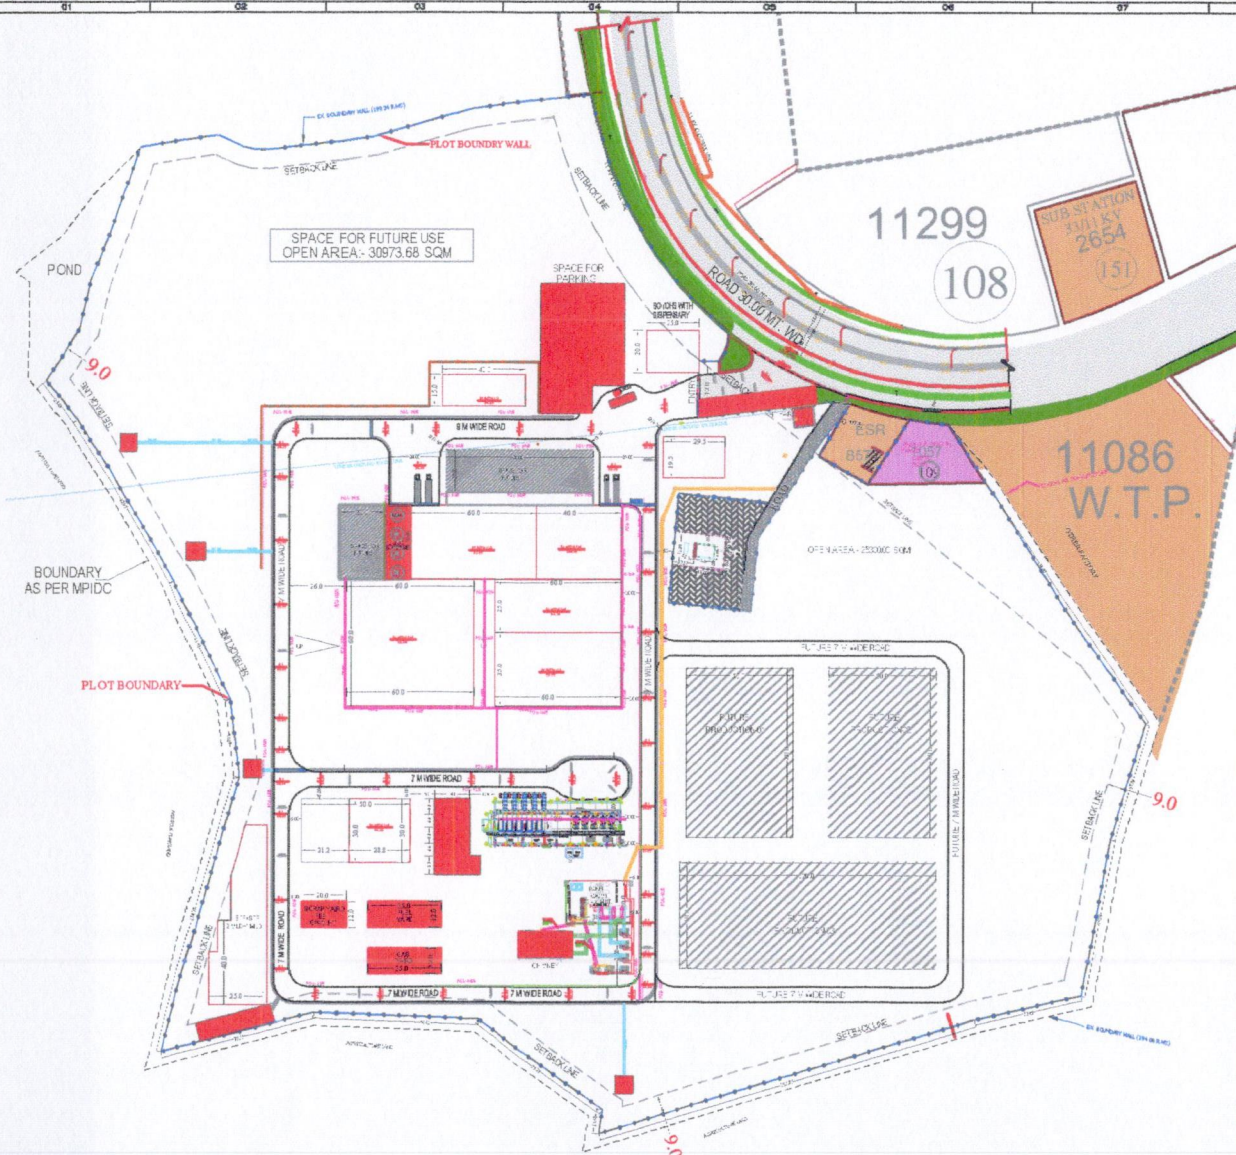


PLOT NO-
110,111,112,113,114,115 & 116

MASTER SITE PLAN


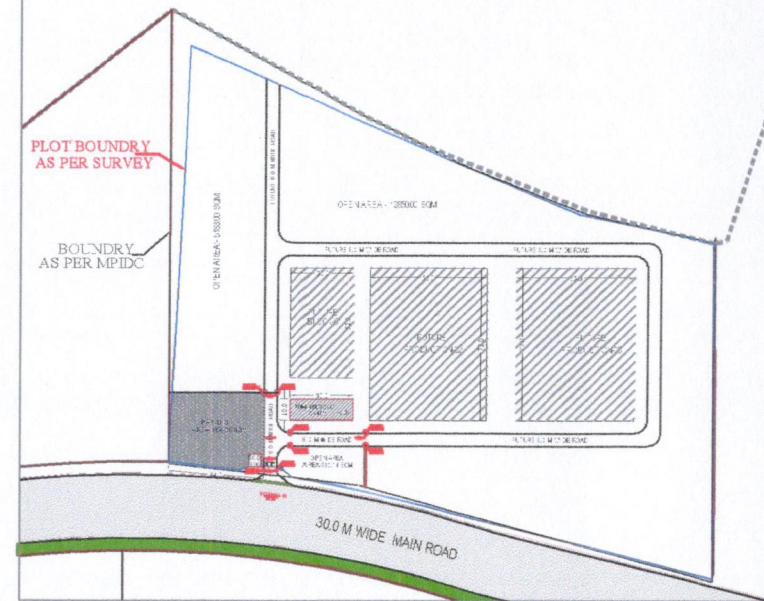


PLOT NO-
103 & 104

LEGEND :-	
PHASE-3	
RETAINING WALL WITH PITCHING	
STORM WATER DRAIN	

 

CLIENT:-	KARNATAKA ANTIBIOTICS AND PHARMACEUTICALS LTD.
PROJECT LOCATION:-	VIKRAM UDYOGPURI, UJJAIN, MP
PROJECT CONSULTANT:-	Doshi Consultants (P) Ltd. SU-CITY, 105-107, 770 M ROAD, INDORE-4 (M.P.) INDIA. PH: (0431) 2511341, 2511342, 2511343, 2511344, 2511345 E-Mail: project@doshiconsultants.com
DRAWING TITLE:	MASTER SITE PLAN
RELEASED FOR:-	TENDER
SCALE: 1"=5'	PROJECT NO: 108
DRAWING NO: 108/47-10-108-108	DATE: 10-10-2010

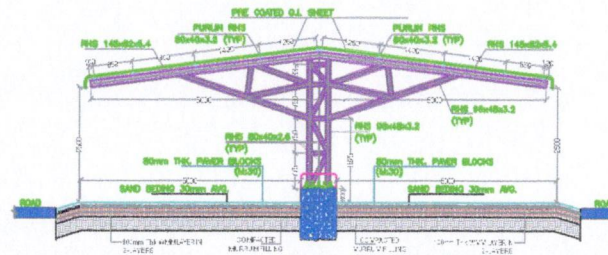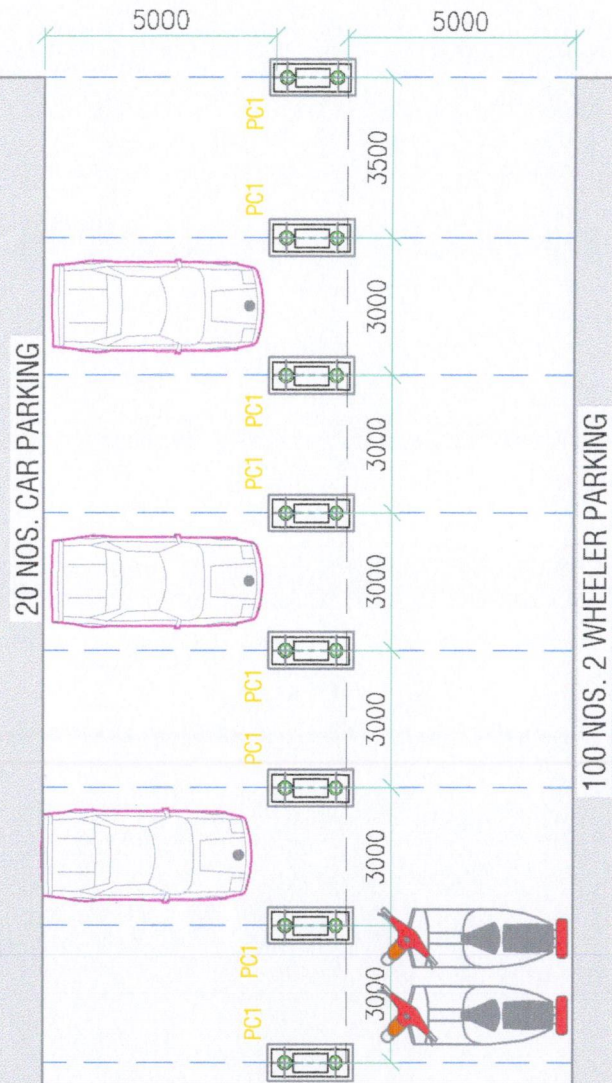

TYPICAL SECTION OF CAR PARKING SHED (ONE SIDE)



NOTES:

1. ALL DIMENSIONS AND SIZES ARE INDICATED IN MILLIMETER UNLESS OTHERWISE SPECIFIED.
2. ALL ELEVATIONS LEVEL ARE INDICATED IN METER UNLESS OTHERWISE SPECIFIED.
3. FOR ACTUAL ELEVATIONS LEVEL REFER TO CIVIL DRAWINGS.
4. THE DRAWING MUST BE READ IN CONJUNCTION WITH ALL ARCHITECTURAL, STRUCTURAL AND OTHER ENGINEERING DRAWINGS.
5. THE CONTRACTOR MUST VERIFY ALL DIMENSIONS AT SITE AND REPORT ABOUT ANY DISCREPANCIES TO THE CONSULTANTS.

NO.	DATE	BY	CHKD	DATE	BY
CLIENT >					
KARNATAKA ANTIBIOTICS AND PHARMACEUTICALS LTD.					
PROJECT LOCATION >					
VIKRAM UDYOGPURI, UJJAIN, MP					
Doshi Consultants (P) Ltd.					
RELEASE FOR >					
TENDER					
PROJECT >					
FERMENTER PLANT					
TITLE >					
TYPICAL DETAIL OF PARKING SHED FOR 4 WHEELER & 2 WHEELER					
DESIGN	3RD	22-21-23	PROJECT NAME	SCALE: N/S	
DESIGN	3RD	22-21-23	PROJECT NO.	626/KAPL/WH/GEN-02A	
DESIGN	3RD	22-21-23	PROJECT NO.	R-0	